

PROPOSED

SHUL

8 HENREY COURT
MONTEBELLOW, NY 10901
S.B.L.: 48.10-1-36

CONSULTING

MAYMO DESIGN
ASSOCIATES

845-422-5516
1828 51ST ST
BROOKLYN NY

GENERAL DISCLAIMER

The architect shall not have control or charge of, and shall not be responsible for construction means, methods, deviations, techniques, sequences, or procedures, or for safety precautions and programs in connection with the work, or for the acts or omissions of the contractor, subcontractors or any other person performing any of the work, or for the failure of any of them to carry out the work in accordance with the contract documents. Always use dimensions as shown, and drawings are not to be scaled. All dimensions to be field verified.

REVISIONS

NO.	DATE

APPLICANT

CHUN ENGINEERING
CONSULTANT, PLLC

77-14 113TH STREET #50
FOREST HILLS, NY 11375


PROJECT LOCATION:

8 HENREY COURT
MONTEBELLOW, NY 10901
S.B.L.: 48.10-1-36

SHEET TITLE

TITLE

SEAL & SIGNATURE

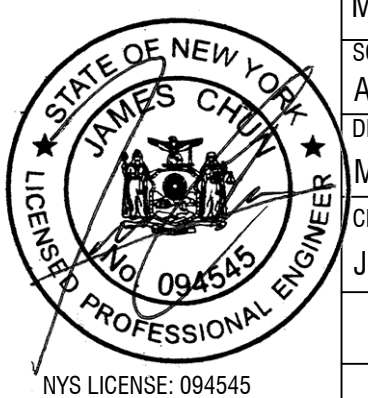

DATE

MAY 7, 2024

SCALE

AS NOTED

DRAWN BY

MF

CHECKED BY

JC



T-001.00

01 OF 3

APPLICATION NUMBER:


HATCHED AREA: EXISTING TO REMAIN

AREA OF WORK

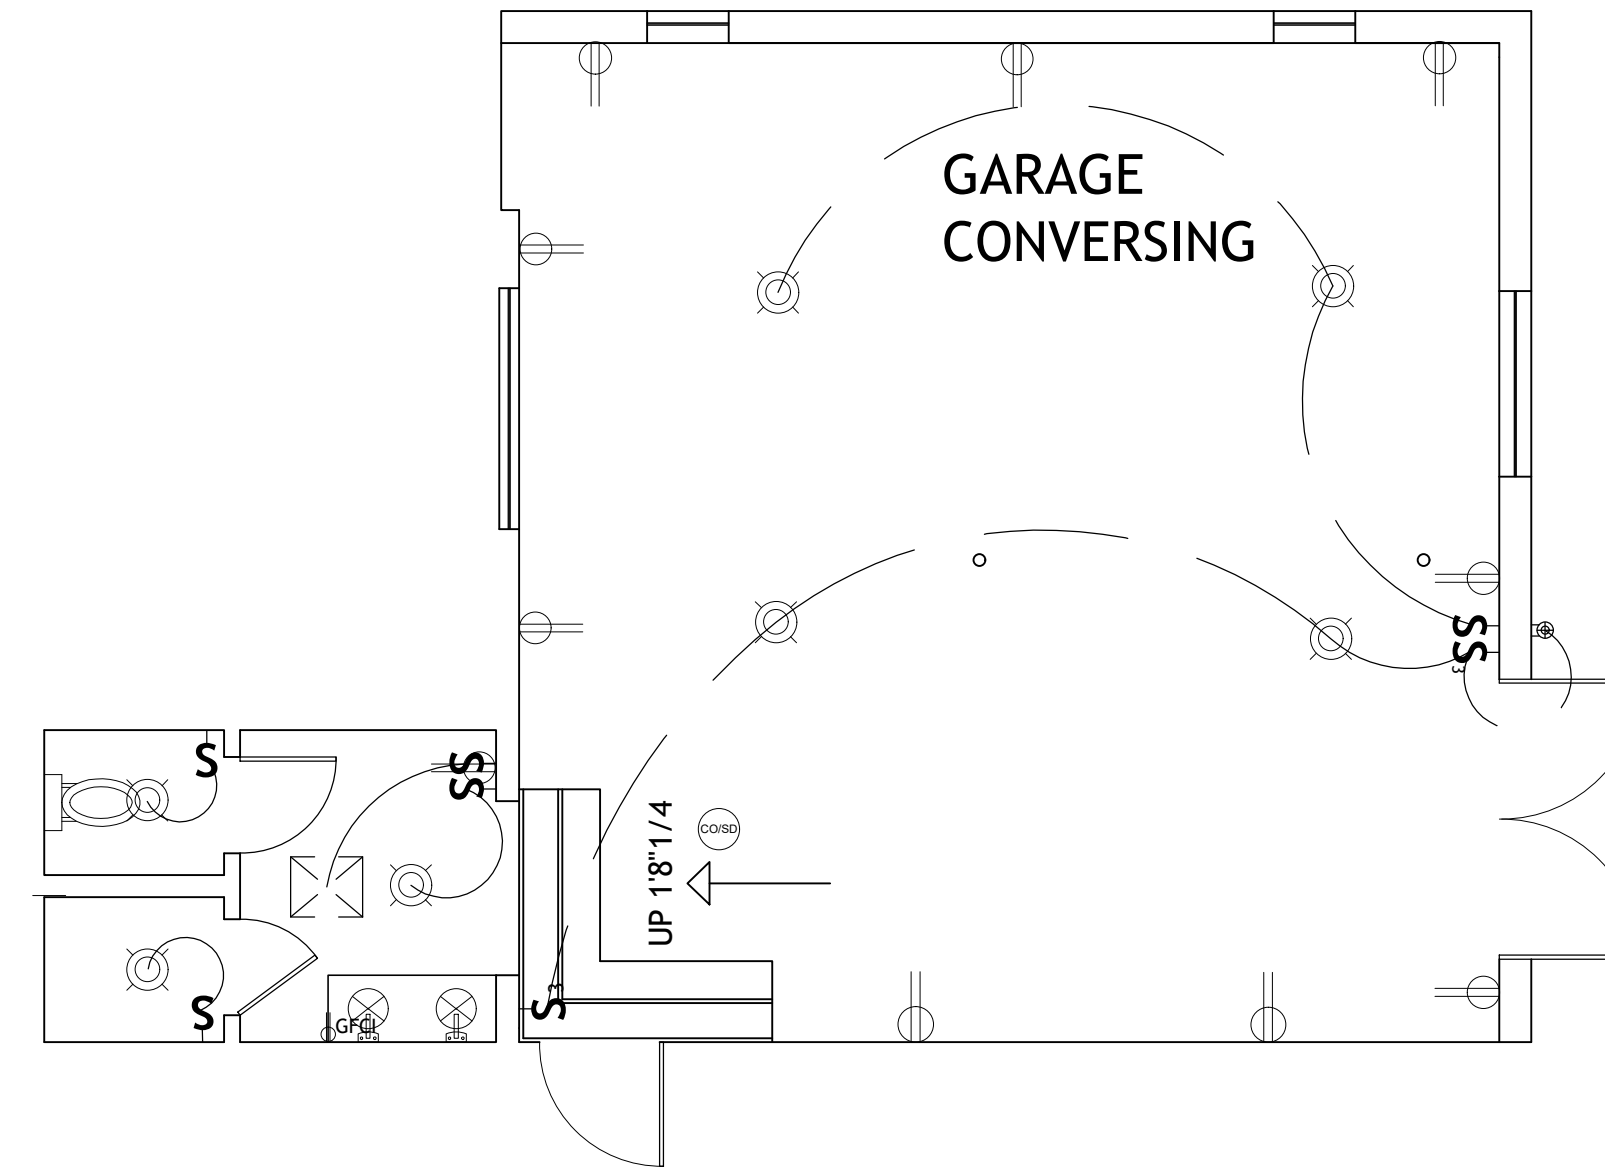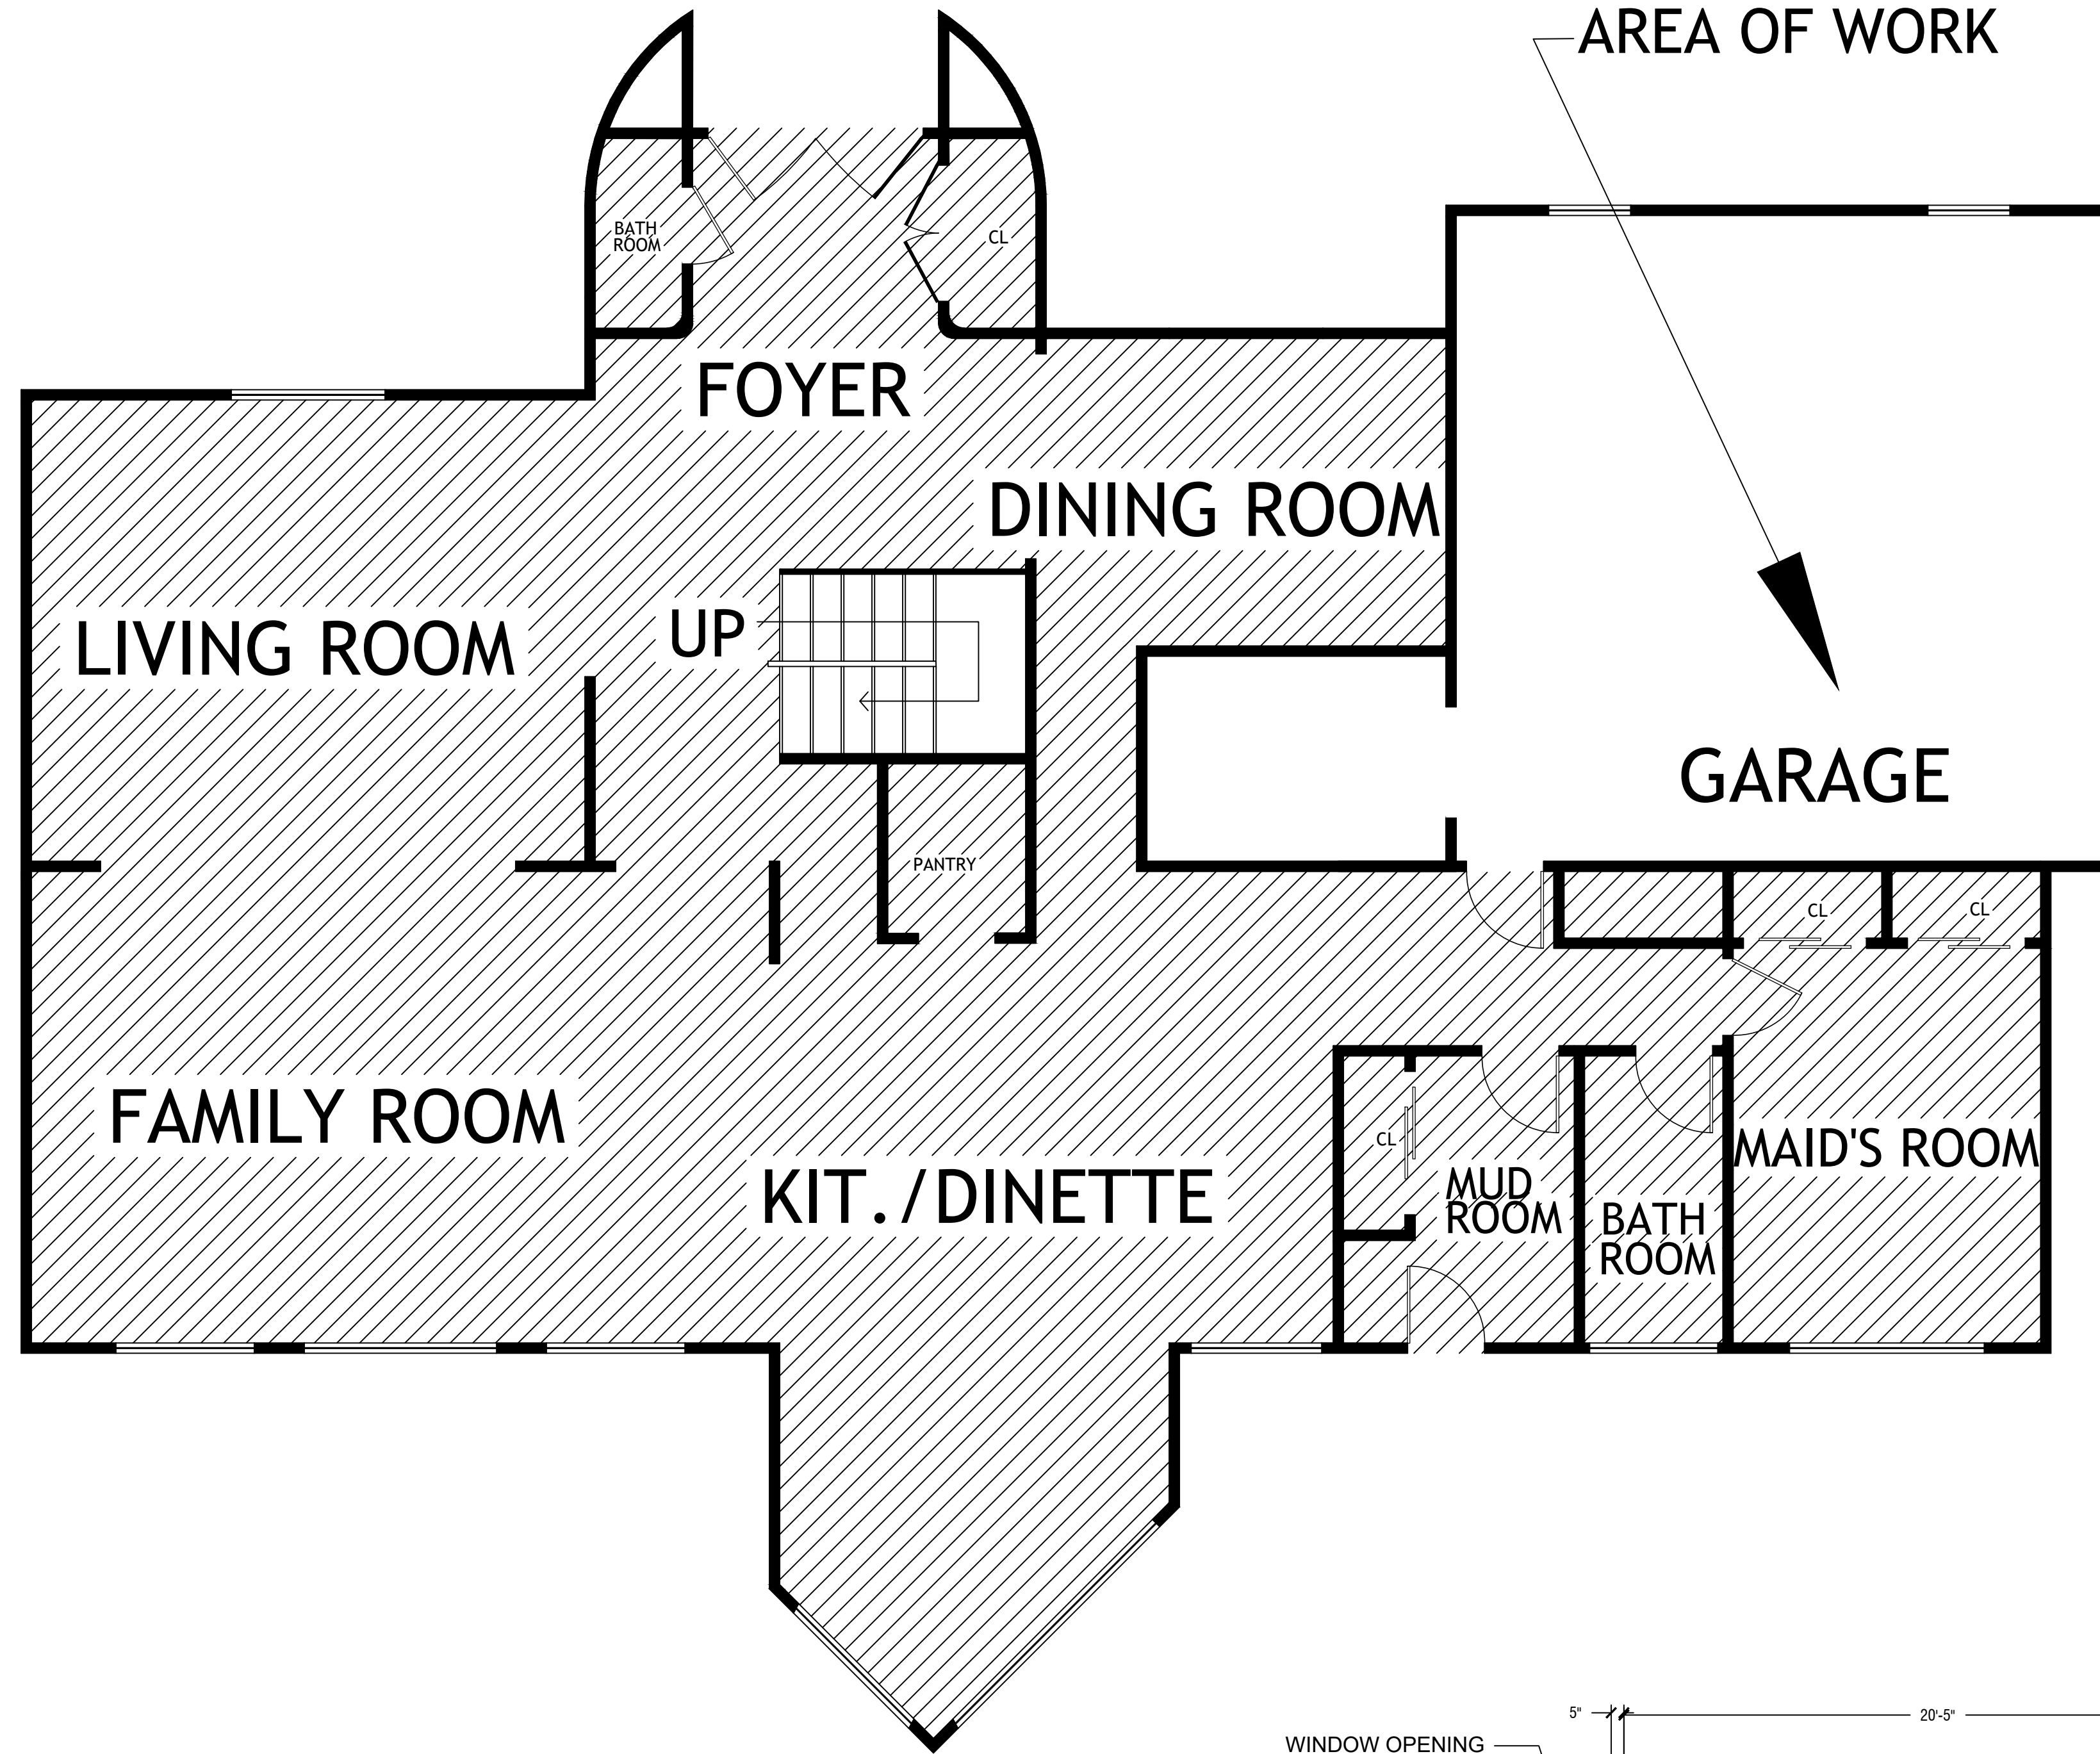


2 LIGHTING RCP
Scale: 1/4" = 1'-0"


ELECTRICAL LEGEND	
SYMBOL	DESCRIPTION
	Exhaust
	Ceiling Mounted Light Fixtures; Surface/Pendant, Recessed, Heat Lamp, Low Voltage
	110V Receptacles: Duplex, Weather Proof, GFCI
	Switches: Single Pole, Weather Proof, 3-Way, 4-Way
	Co & Smoke Detectors: Ceiling Mounted, Wall Mounted
	Co Detectors: Ceiling Mounted, Wall Mounted
	Smoke Detectors: Ceiling Mounted, Wall Mounted

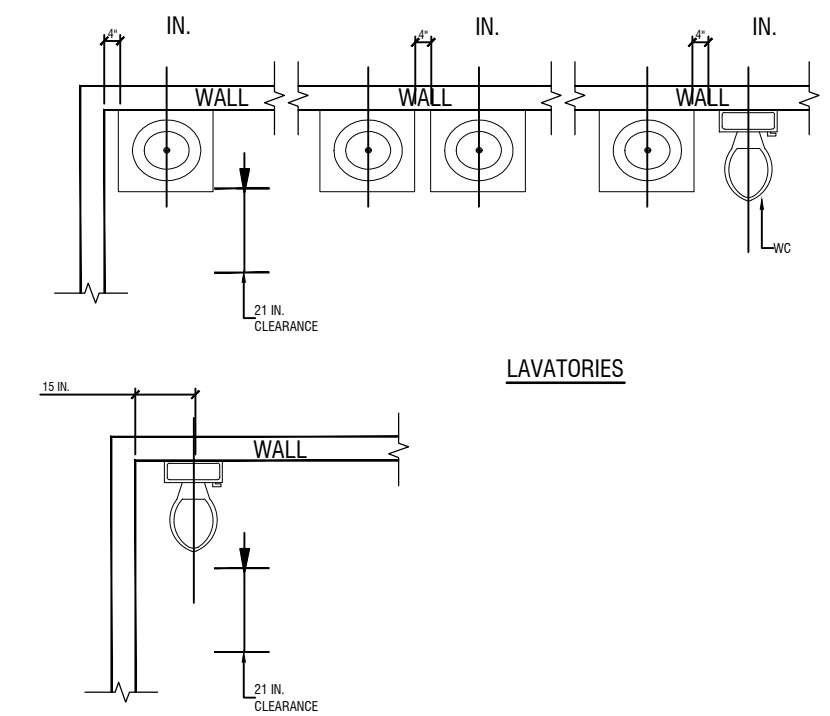

4 BATHROOM FIXTURE CLEARANCE

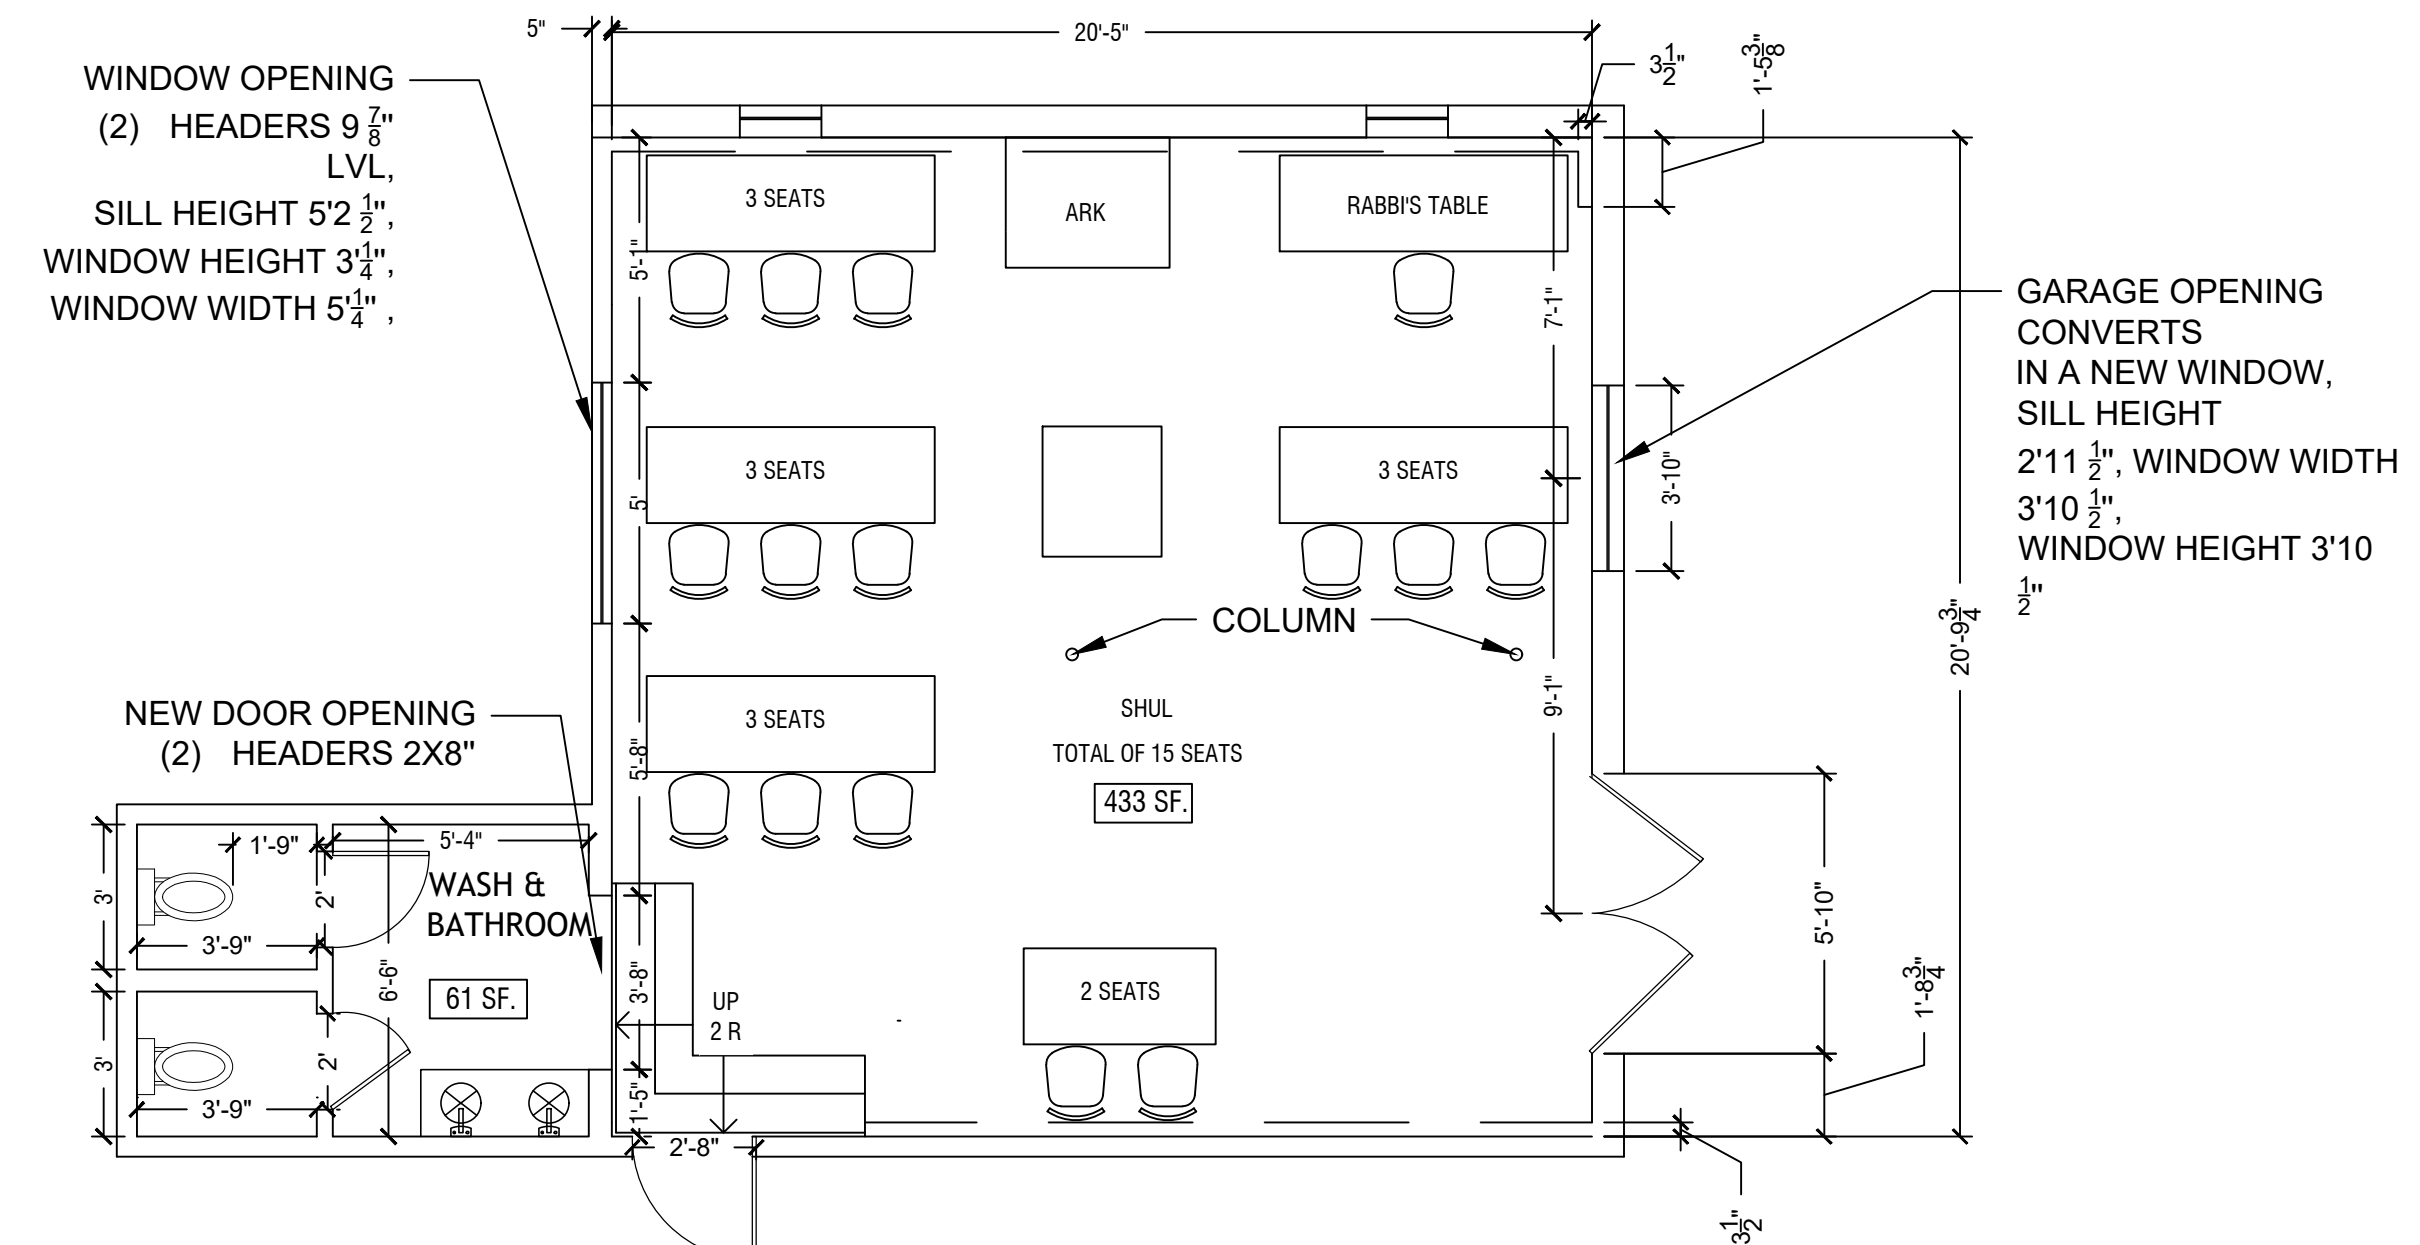

1 FLOOR PLAN
Scale: 1/4" = 1'-0"

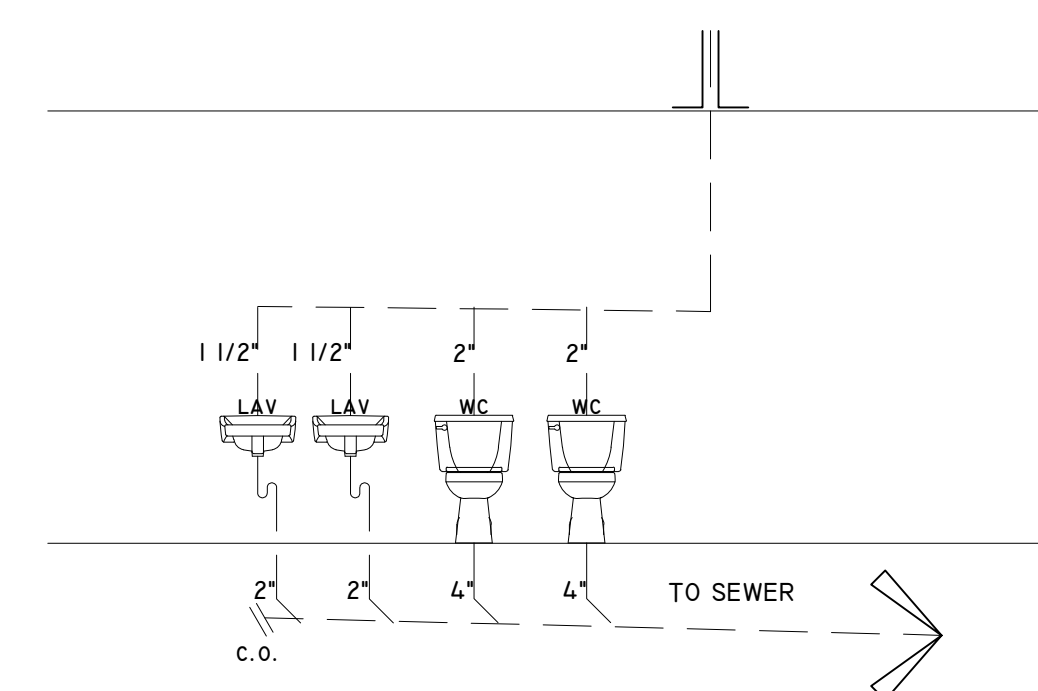

3 PLUMBING RISER DIAGRAM
Scale: NTS

CONSULTING
MAYMO DESIGN ASSOCIATES
845-422-5516
1828 51ST ST
BROOKLYN NY

GENERAL DISCLAIMER
The architect shall not have control or charge of, and shall not be responsible for construction means, methods, deviations, techniques, sequences, or procedures, or for safety precautions and programs in connection with the work, or for the acts or omissions of the contractor, subcontractors or any other person performing any of the work, or for the failure of any of them to carry out the work in accordance with the contract documents. Always use dimensions as shown, and drawings are not to be scaled. All dimensions to be field verified.

REVISIONS

NO.	DATE:

APPLICANT
CHUN ENGINEERING CONSULTANT, PLLC
77-14 113TH STREET #50
FOREST HILLS, NY 11375

PROJECT LOCATION:
8 HENREY COURT
MONTEBELLOW, NY 10901
S.B.L.: 48.10-1-36

SHEET TITLE
FLOOR PLANS

SEAL & SIGNATURE	DATE MAY. 7, 2024
	SCALE AS NOTED
	DRAWN BY JMF
	CHECKED BY JJC
A-100.00	
03 OF 3	

APPLICATION NUMBER: